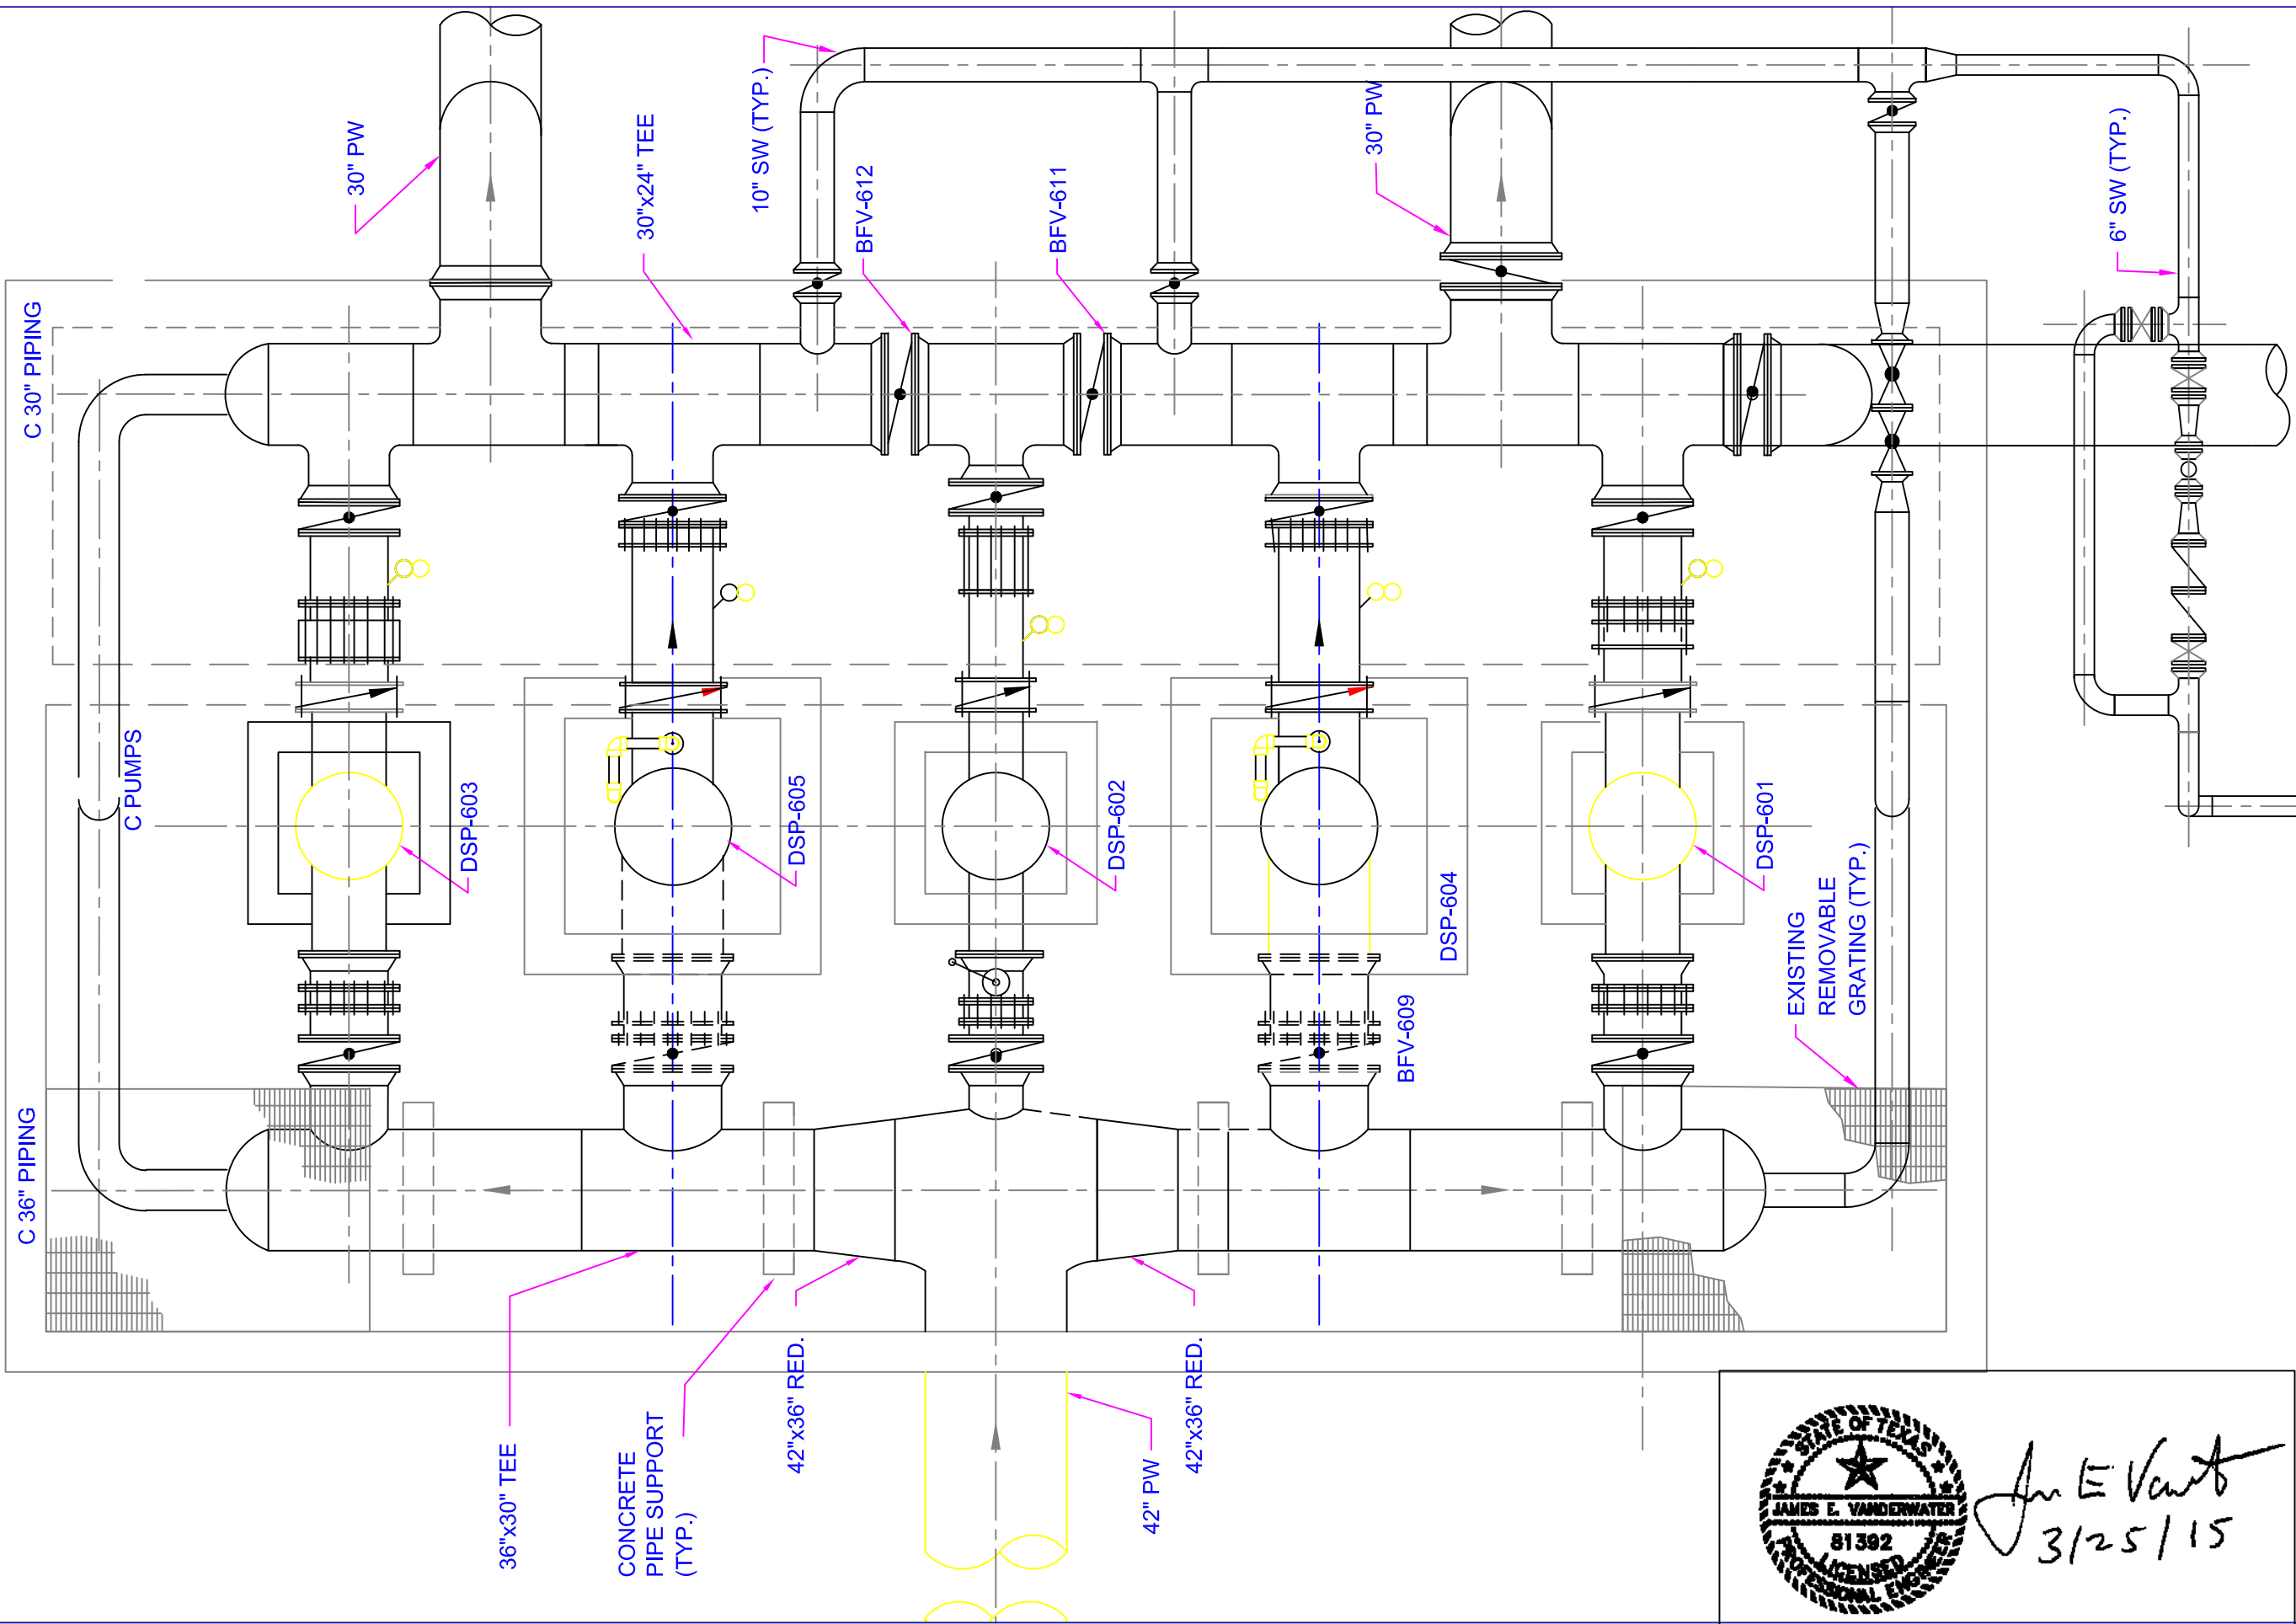

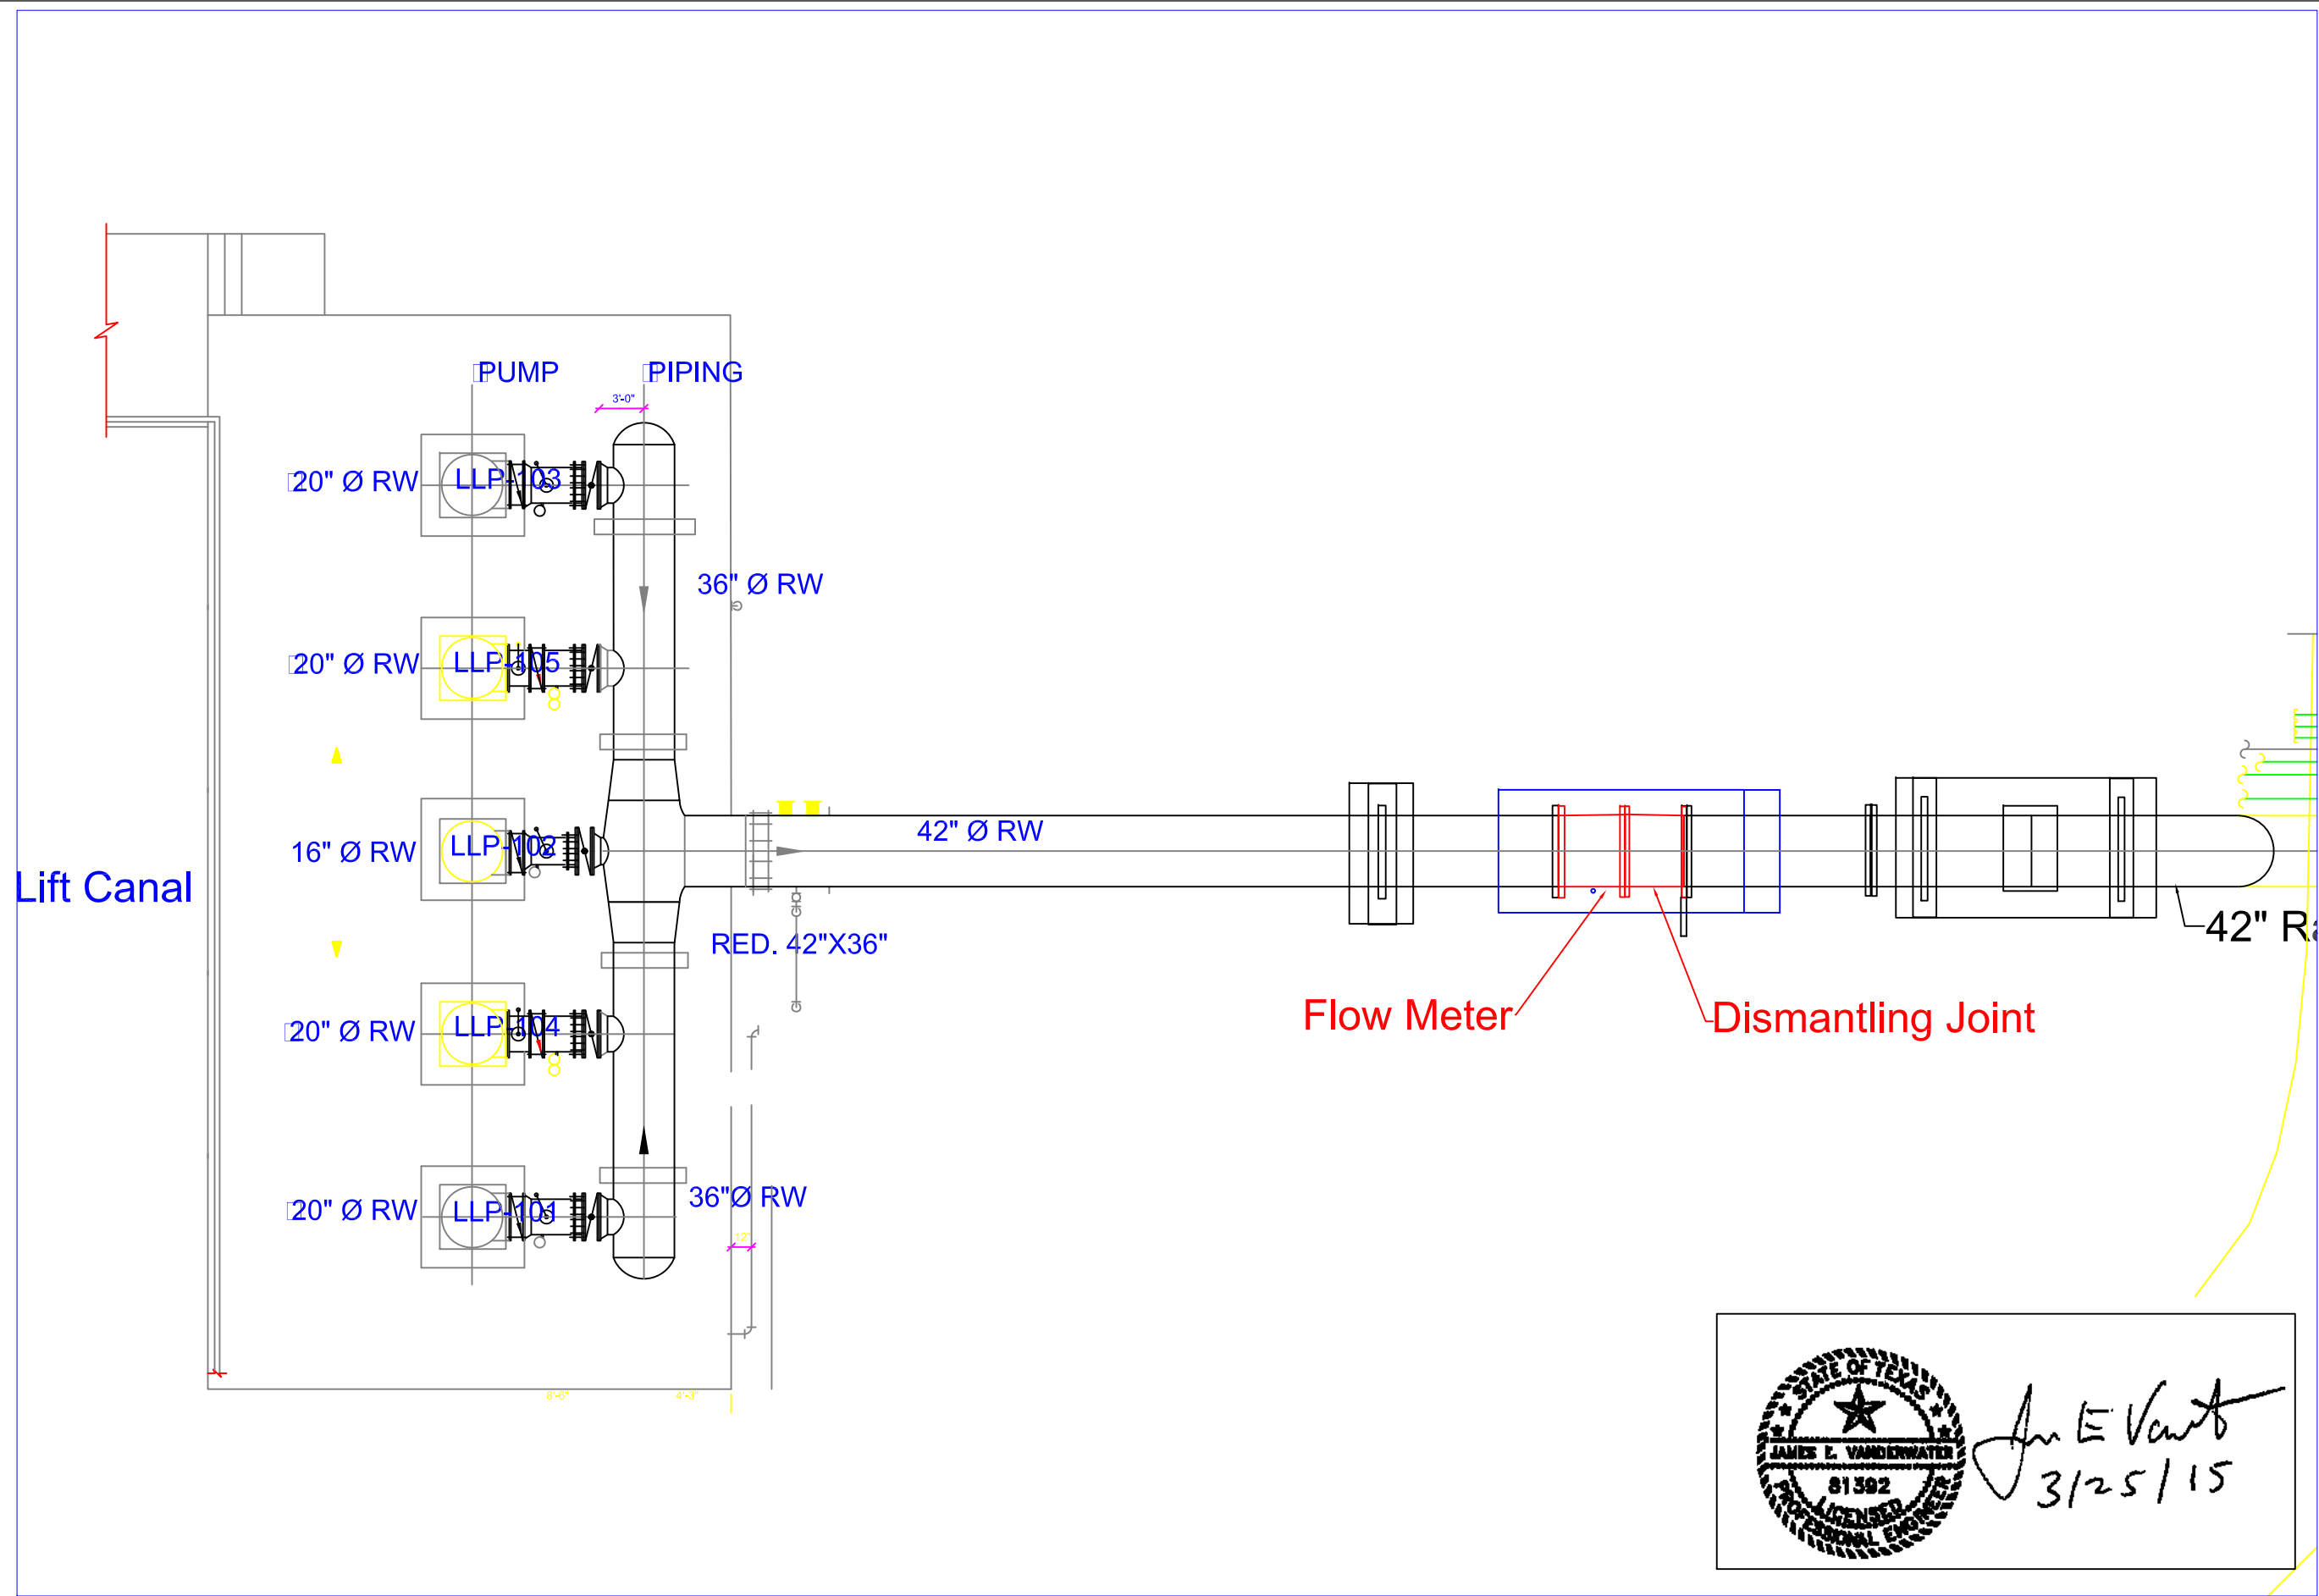


BORDER.DWG



James E. Vanderwater
3/25/15


 Gulf Coast Water Authority	PREPARED: JEV CHECKED: JEV APPROVED:	PROJECT 06.20.20150320 DISTRIBUTION AND LOW LIFT PAINTING PIPING LAYOUT DISTRIBUTION HEADER	REV DESCRIPTION DATE APPR
	DATE: 03/25/2015 SCALE: 1/4" = 1' SHEET NUMBER C-1		



REV	DESCRIPTION	DATE	APPR

PROJECT 06.20.20150320	DISTRIBUTION AND LOW LIFT PAINTING	PIPING LAYOUT
LOW LIFT HEADER AND PIPE		

PREPARED: JEV	CHECKED: JEV	APPROVED:
---------------	--------------	-----------



James E. Vanderwater

 3/25/15

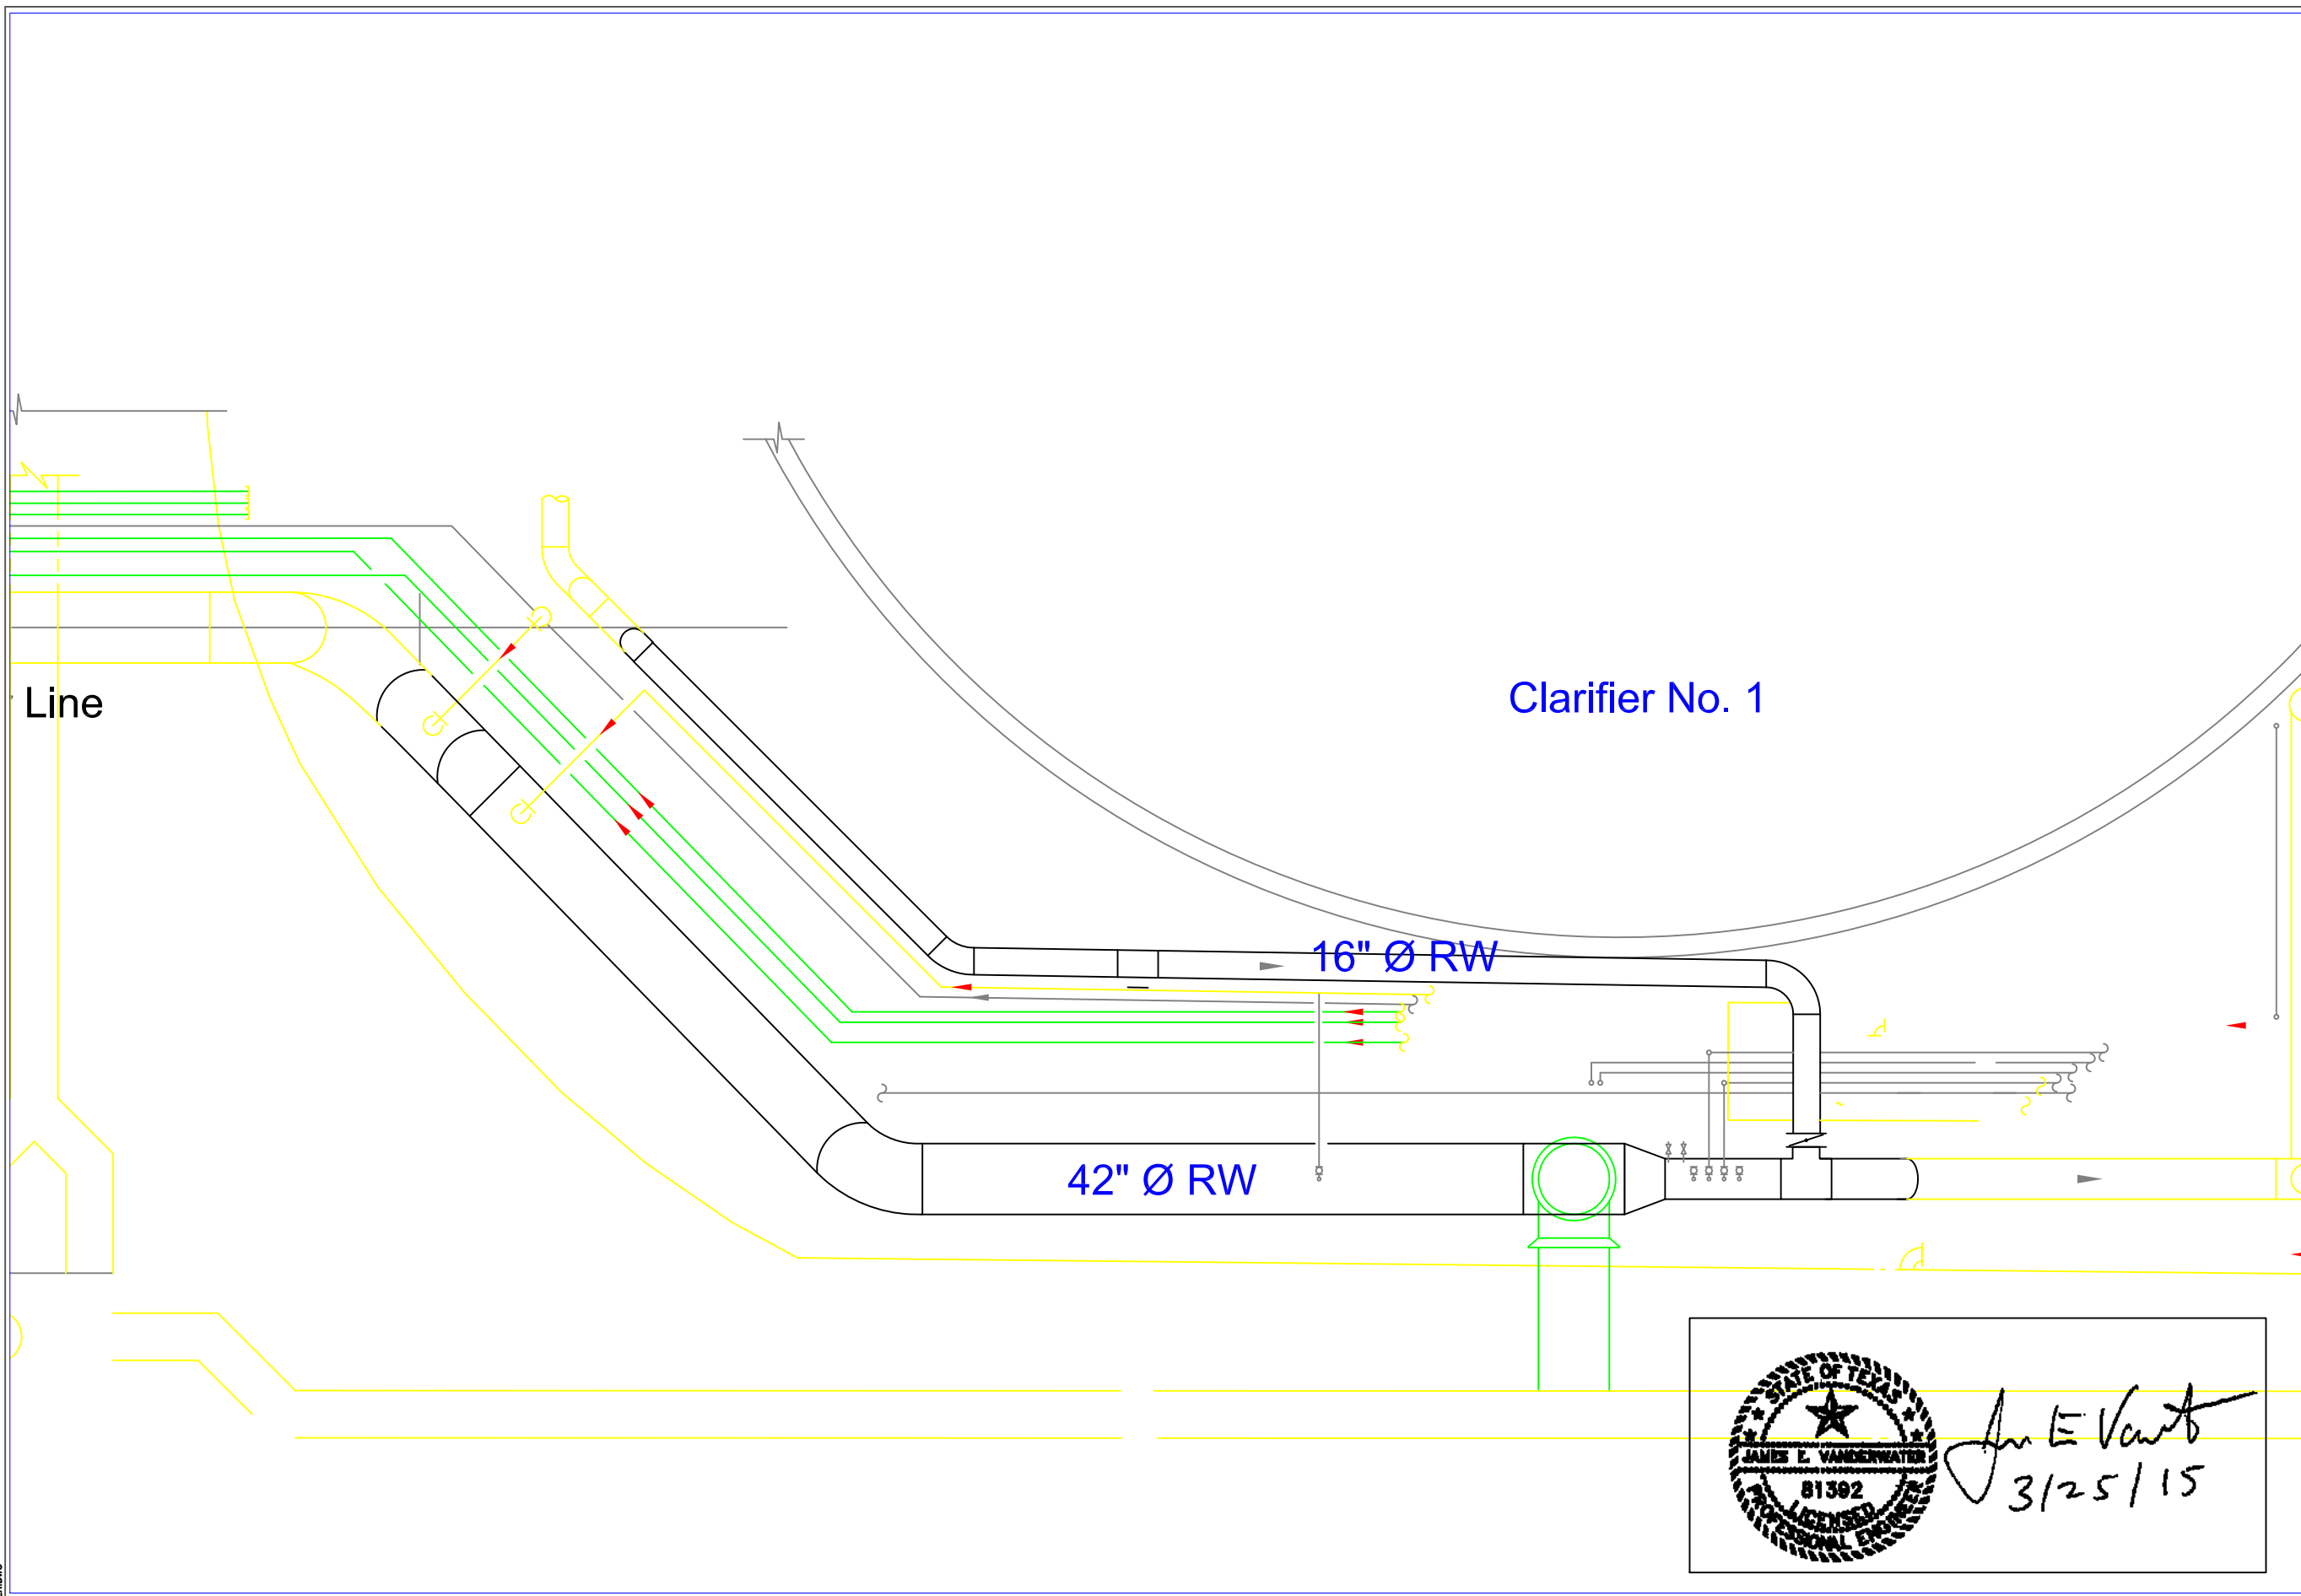


GCWA


 Gulf Coast Water Authority

DATE: 03/25/2015
 SCALE: 1/8" = 1'
 SHEET NUMBER
C - 2

BORDER.DWG



BORDER.DWG



James L. Vanderwater

 3/25/15

DATE	APPR		
REV	DESCRIPTION		
PROJECT	06.20.20150320	PREPARED:	JEV
	DISTRIBUTION AND LOW LIFT PAINTING	CHECKED:	JEV
	PIPING LAYOUT	APPROVED:	
	RAW WATER PIPE		



DATE: 03/25/2015
 SCALE: 1/8" = 1'

SHEET NUMBER
C - 3